




1 SECOND FLOOR — ENLARGED ELECTRICAL ROOM  
SCALE: 1/4" = 1'-0"

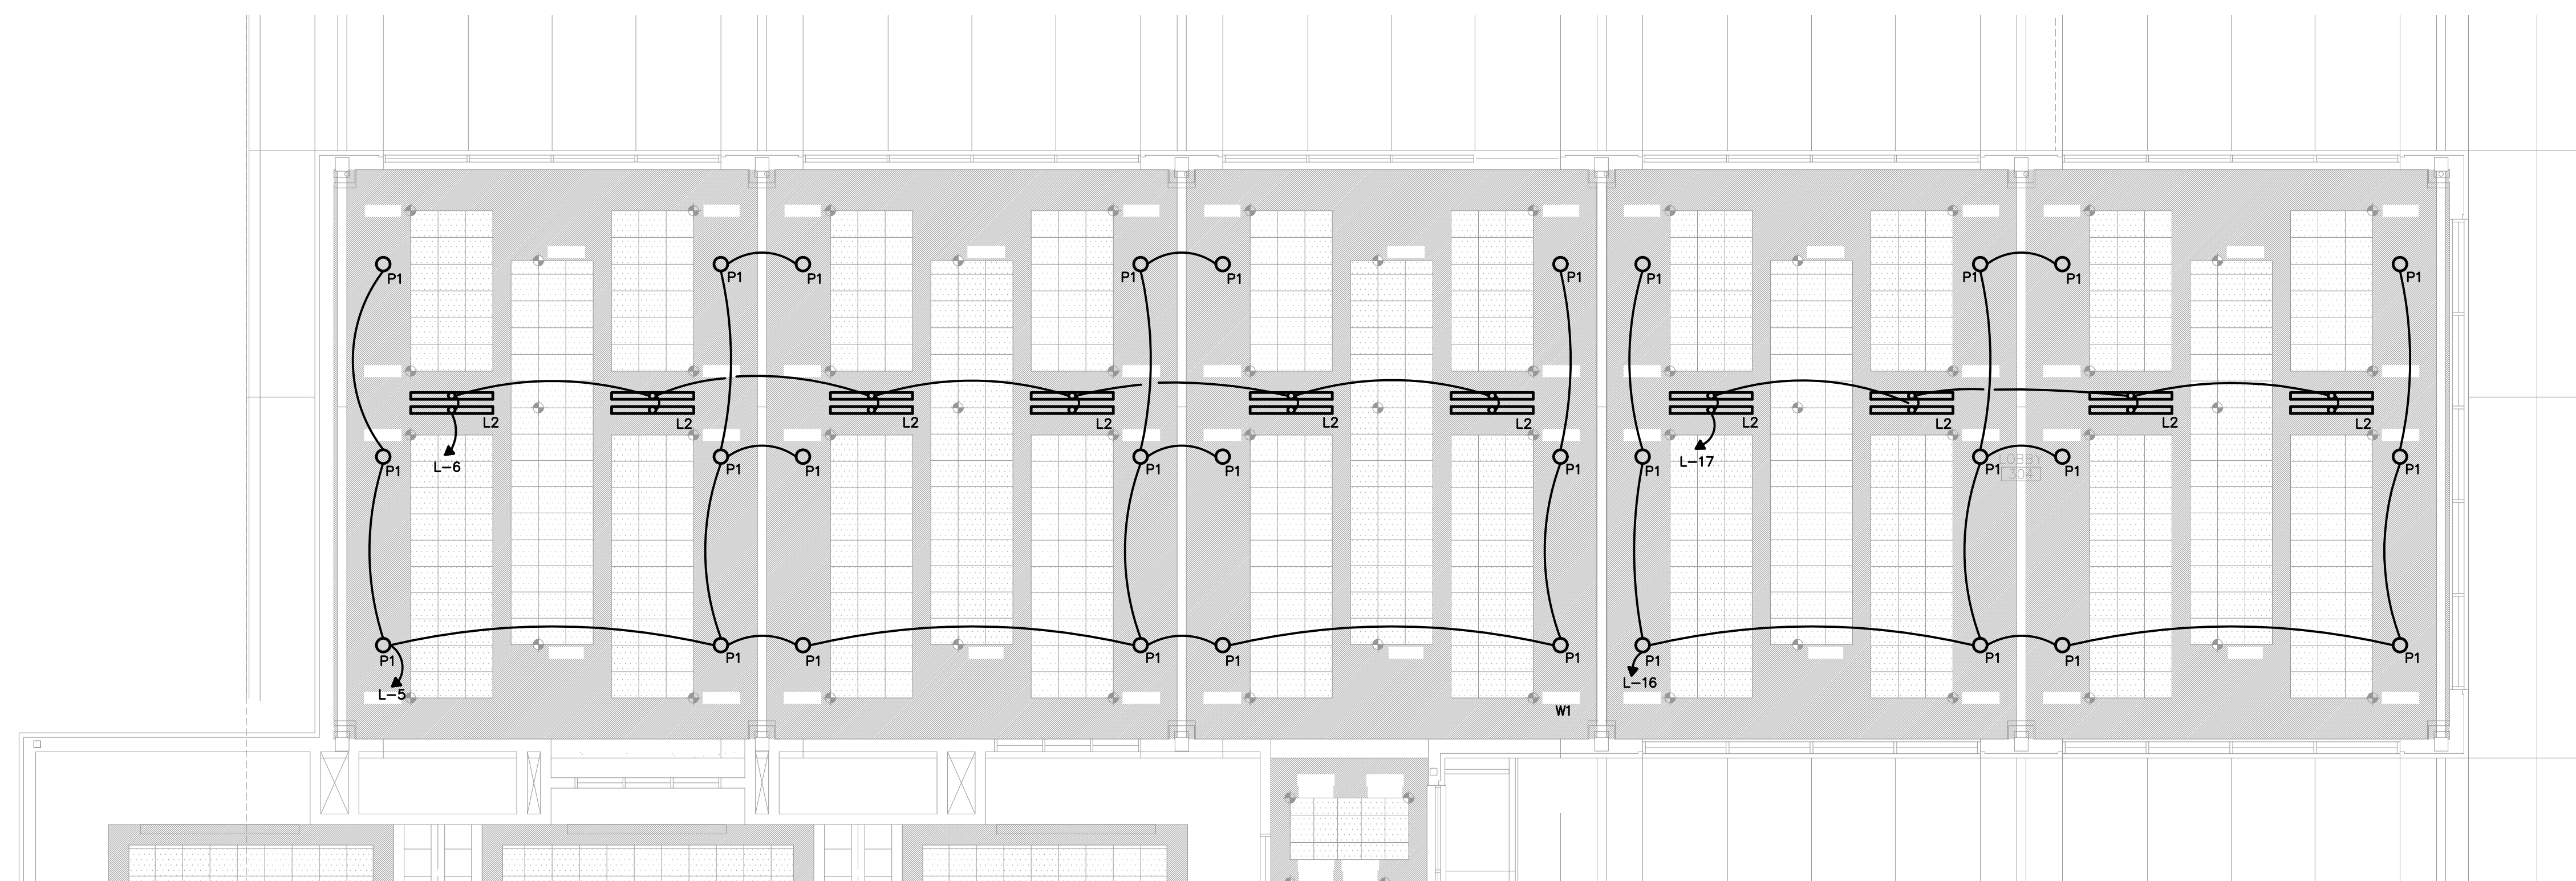


2 SECOND FLOOR — LIGHTING PLAN — HIGH CEILING  
SCALE: 1/8" = 1'-0"

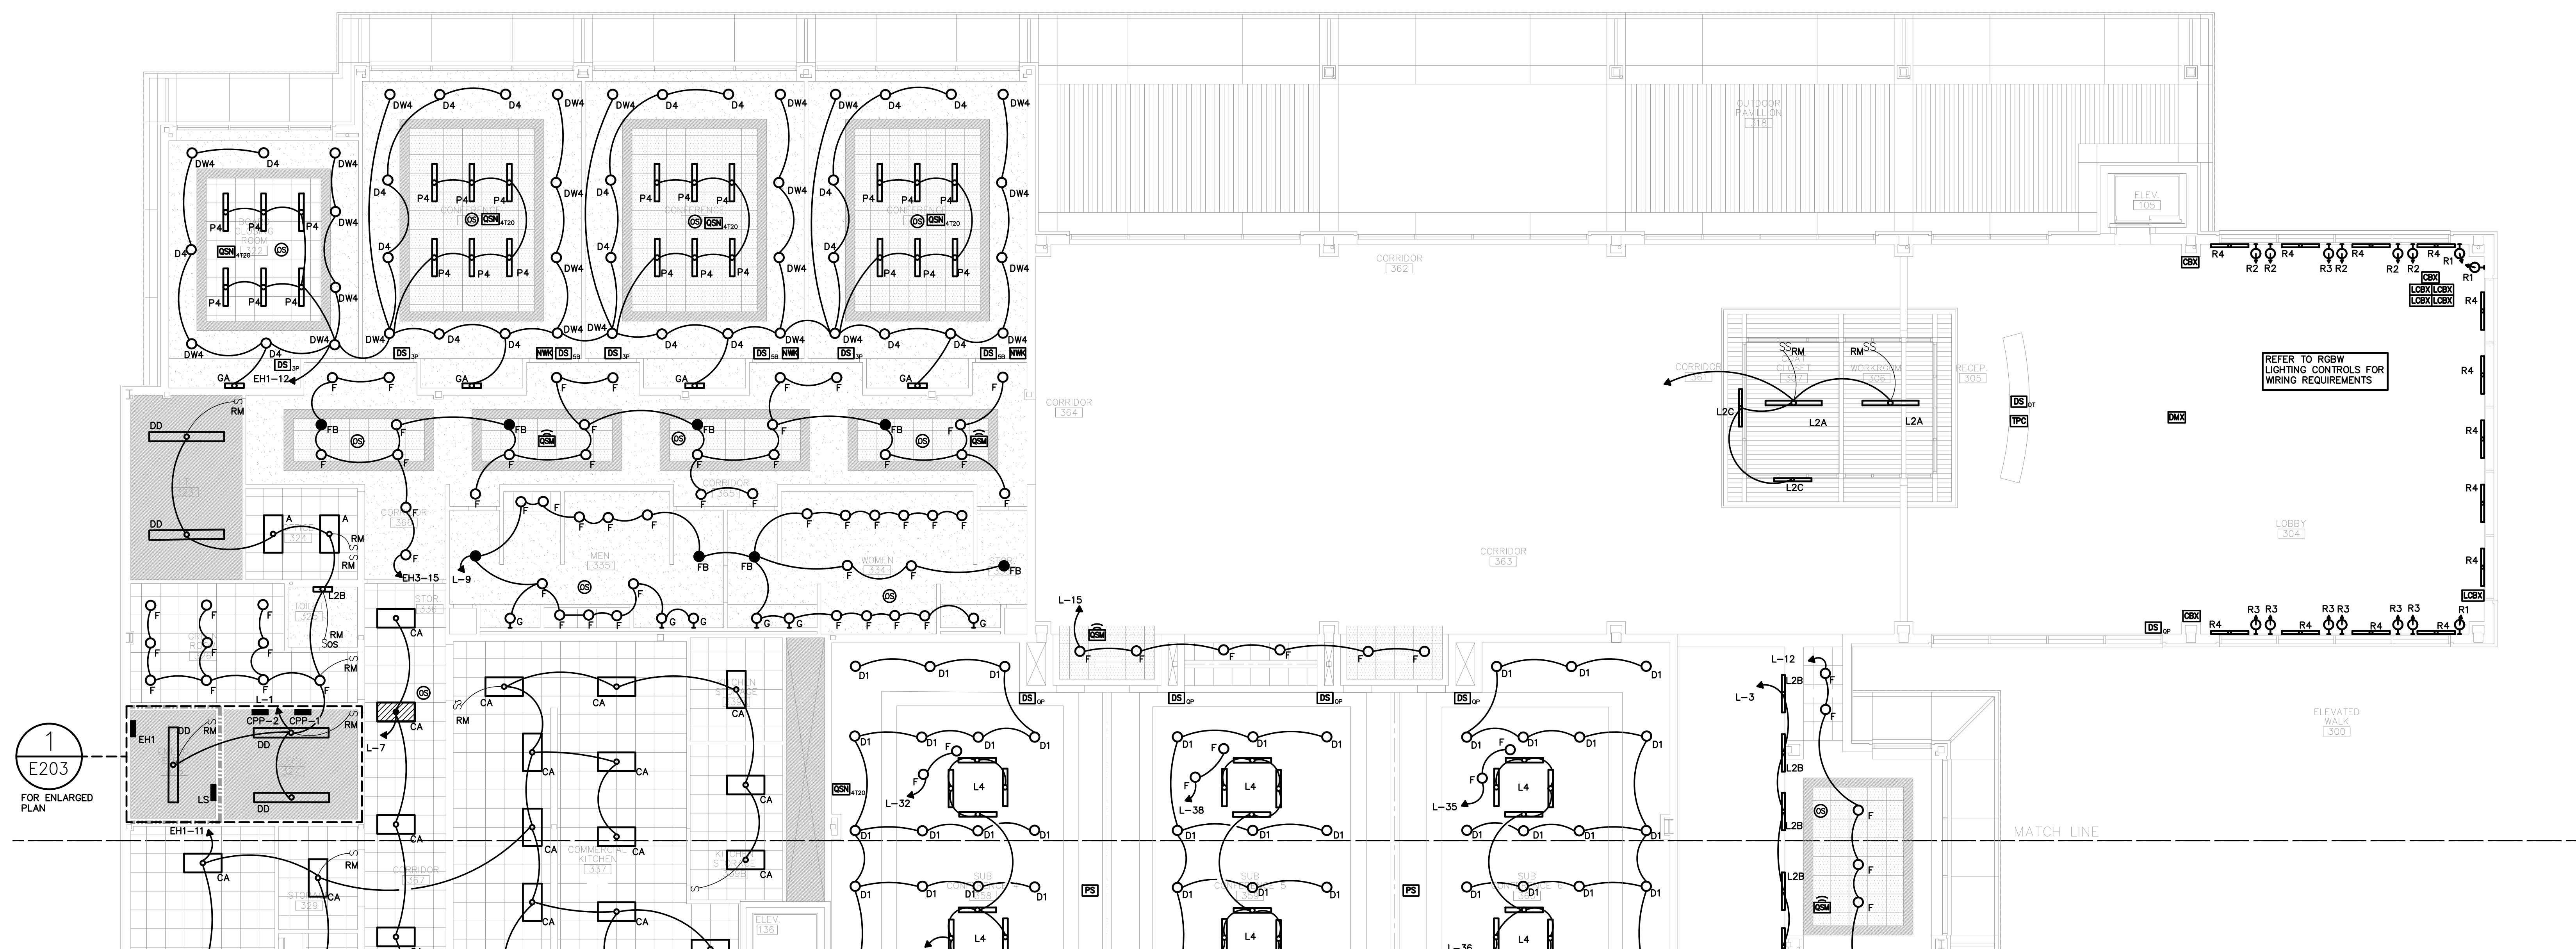

3 SECOND FLOOR — LIGHTING PLAN — AREA A  
SCALE: 1/8" = 1'-0"

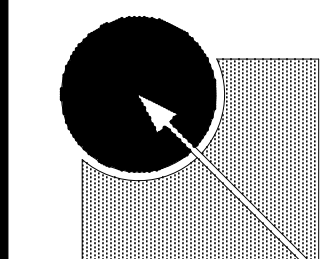

McKNIGHT • SMITH • WARD • GRIFFIN  
ENGINEERS, INCORPORATED  
PO Box 240826 • 4223 South Boulevard  
Charlotte, NC 28224 • 704/527-2112

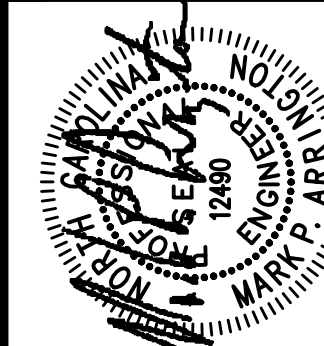

JOB NUMBER	REVISION DATES
22-168	
DESIGNED BY	CH
CHECKED BY	MPA
DATE	03.06.23

JOB TITLE  
CLEVELAND COUNTY  
LEGRAND CENTER LIGHTING

SHEET TITLE  
SECOND FLOOR LIGHTING PLAN  
AREA A

SHEET  
E203